

200 PINE ST. SUITE 200
 BRAMBLETON, TEXAS 77701
 (409) 866-7196
 FAX (409) 866-1195
 J. IRENE CLARK, AIA
 RONALD M. JONES, AIA
 www.archalliance.com

JAMES R. CLARK, AIA
 TEXAS REG. # 8212
 DATE: 10/2/2018
 THIS DOCUMENT MAY NOT
 BE USED FOR BIDDING,
 PERMITS, OR CONSTRUCTION
 PURPOSES.

RONALD M. JONES, AIA
 TEXAS REG. # 13862
 DATE: 10/2/2018
 THIS DOCUMENT MAY NOT
 BE USED FOR BIDDING,
 PERMITS, OR CONSTRUCTION
 PURPOSES.

Brookeland, Texas

ELEMENTARY SCHOOL ADDITION

Autodesk

Manchester, NH

Consultant

ISSUED FOR SCHEMATIC	<input checked="" type="checkbox"/>
DATE:	
DESIGN DEVELOPMENT	<input type="checkbox"/>
DATE:	
BIDS & CONSTRUCTION	<input type="checkbox"/>
DATE:	
REVISION	<input type="checkbox"/>
DATE:	
REVISION	<input type="checkbox"/>
DATE:	
REVISION	<input type="checkbox"/>
DATE:	



DRAWING SHEET TITLE

POWER & COMMUNICATION FLOOR PLAN

10/12-El.dwg

SHEET NUMBER
E-1


1854 PROJECT NO.

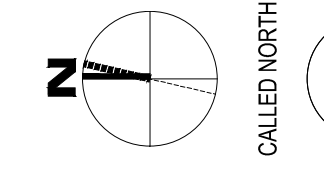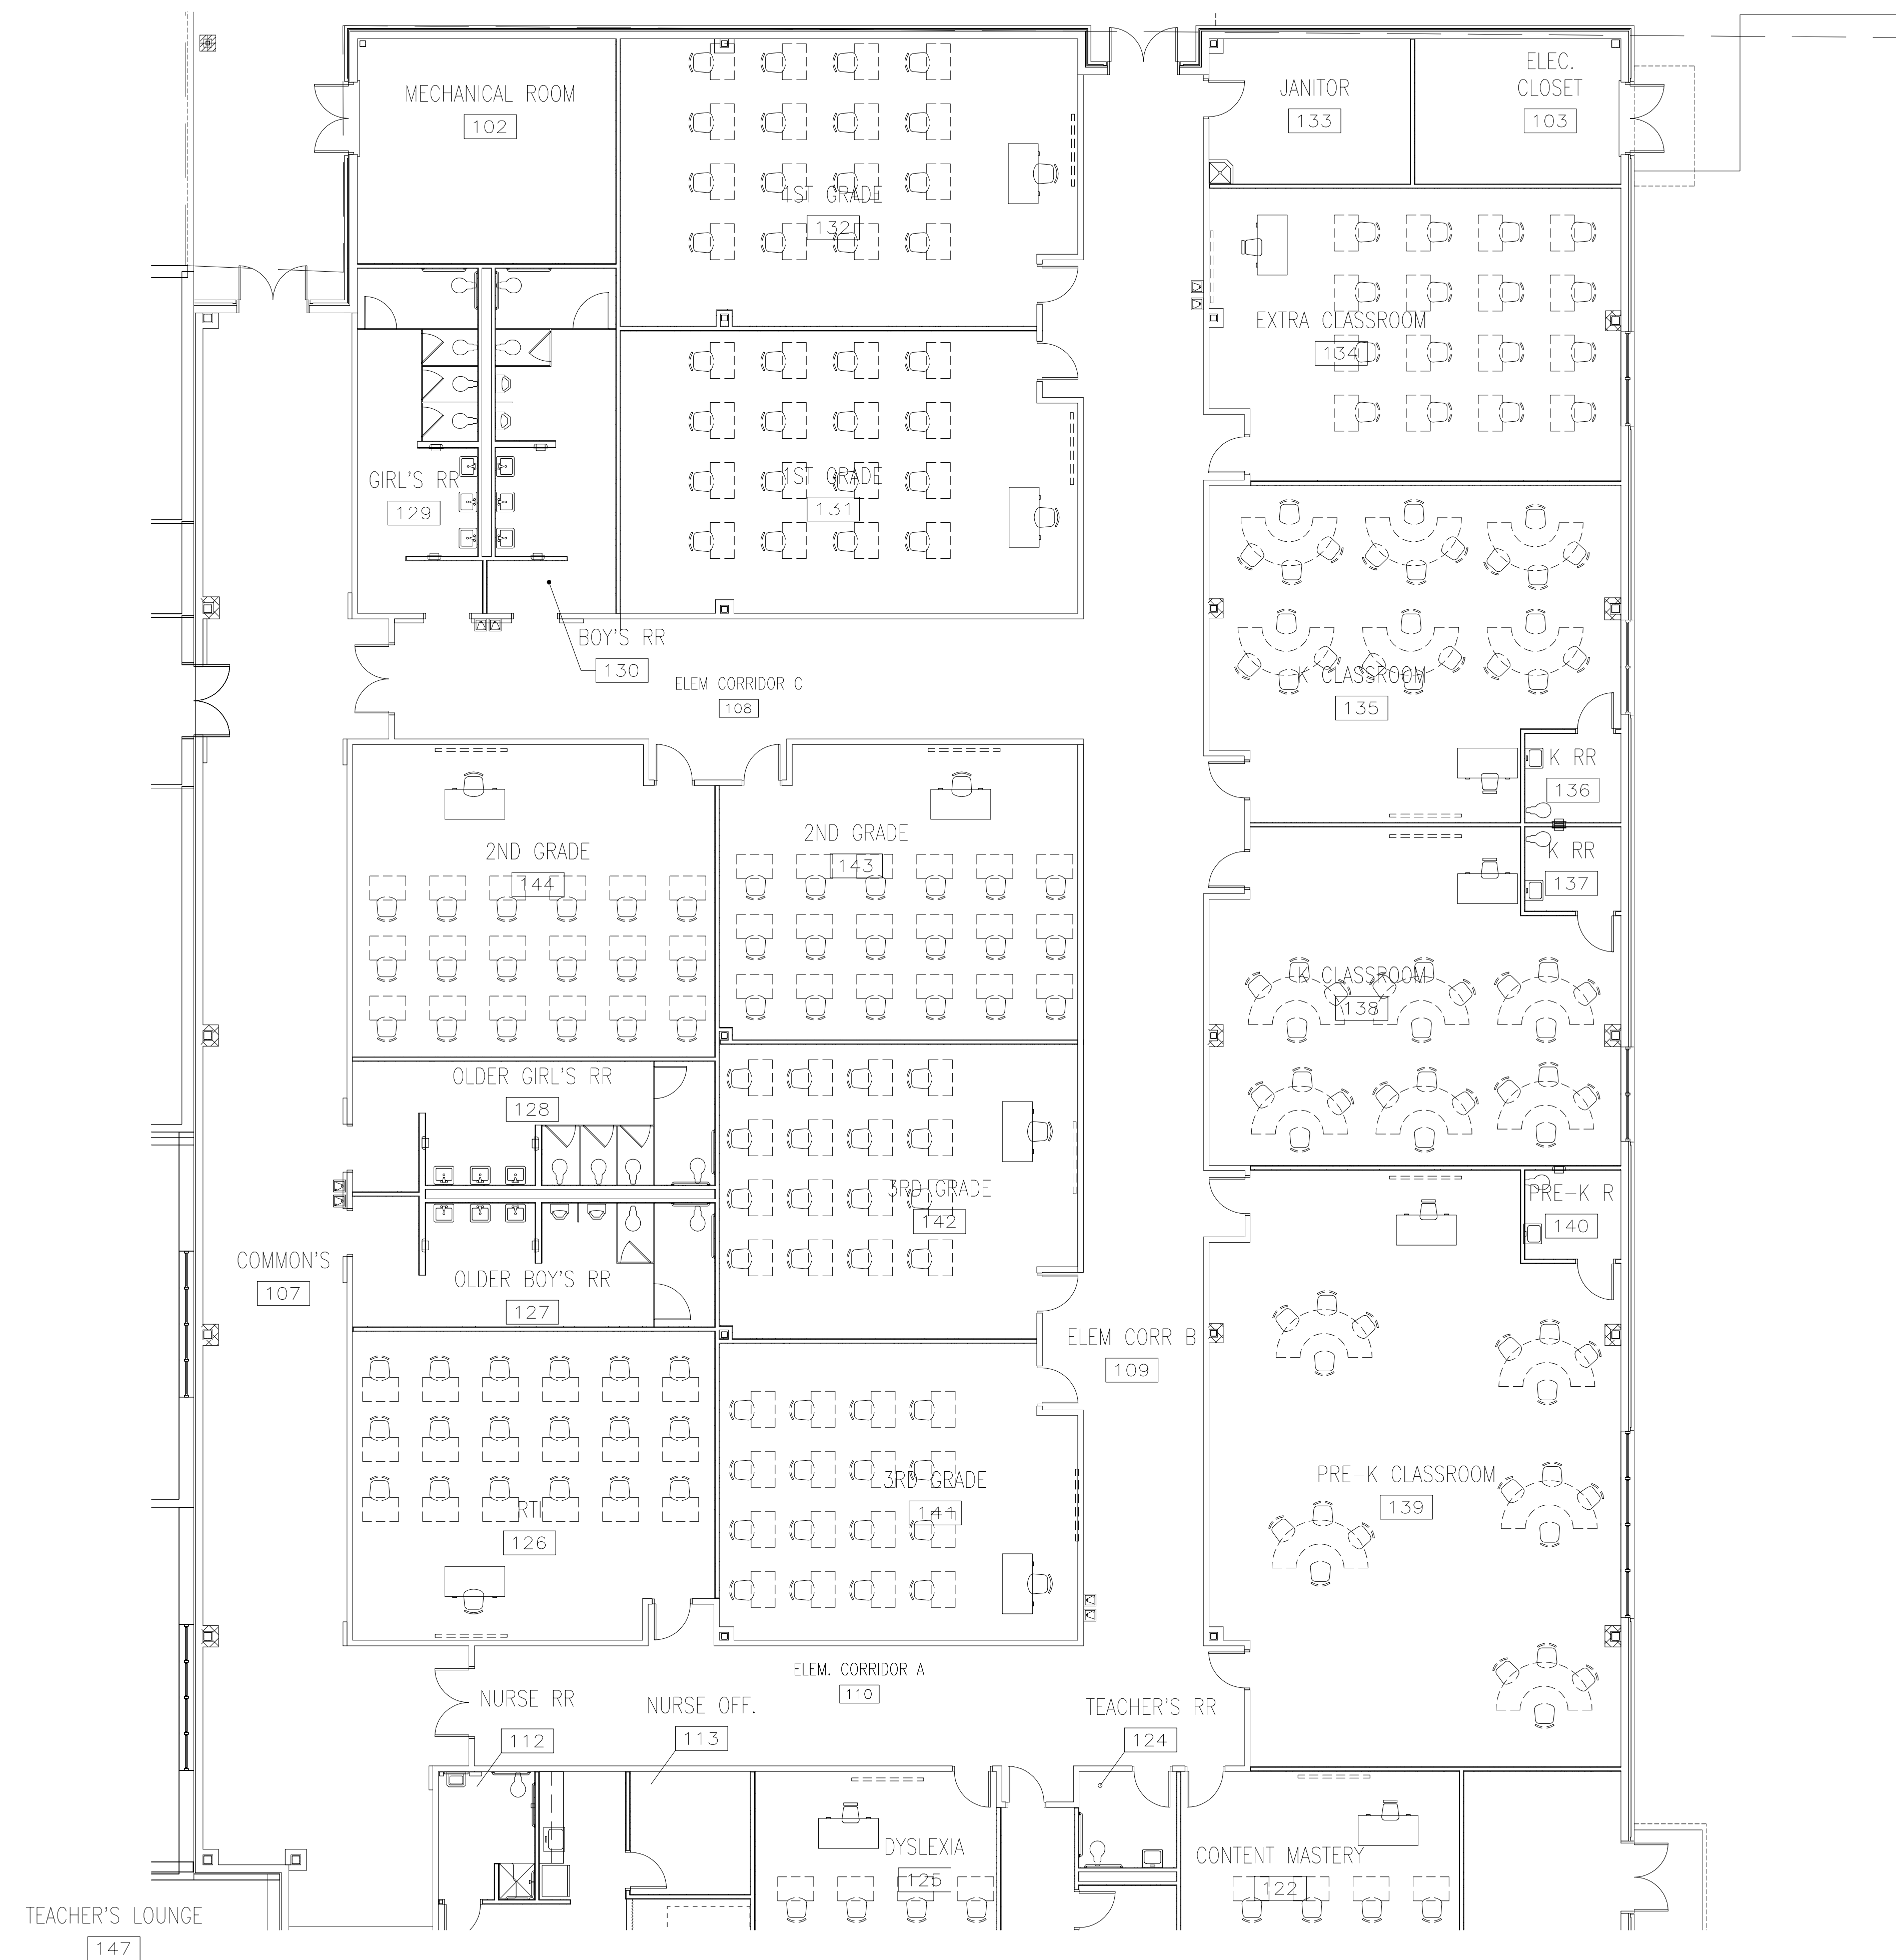

1 POWER & COMMUNICATION FLOOR PLAN

SCALE: 1/8" = 1'-0"

THIS DOCUMENT HAS BEEN ISSUED FOR INTERIM REVIEW AND NOT INTENDED FOR BIDDING, ISSUES OF PERMITS, OR CONSTRUCTION PURPOSES. ISSUED: _____

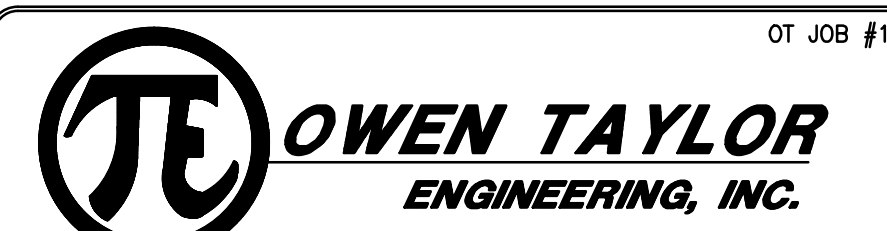

105 S VILLAGE WOODVILLE, TEXAS 75079 TX ST. # F-4765 PHONE (409) 263-5537 FAX (409) 263-3634